



VICINITY MAP
NOT TO SCALE

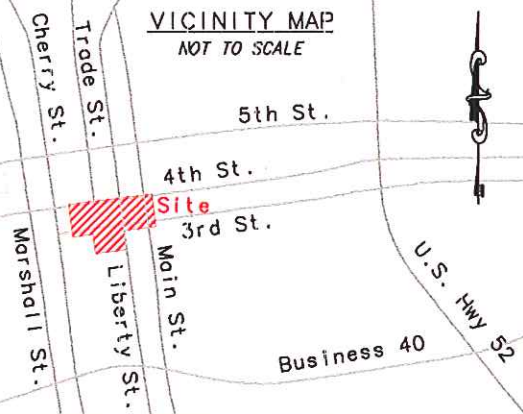

CAVANAUGH

Solutions through integrity and partnership

Overseas Engineering & Associates, P.A. 305 West Fourth Street, Suite 1A, Winston-Salem, NC 27101 336.769.9001 Fax: 336.769.1005 www.cavanaughhsolutions.com

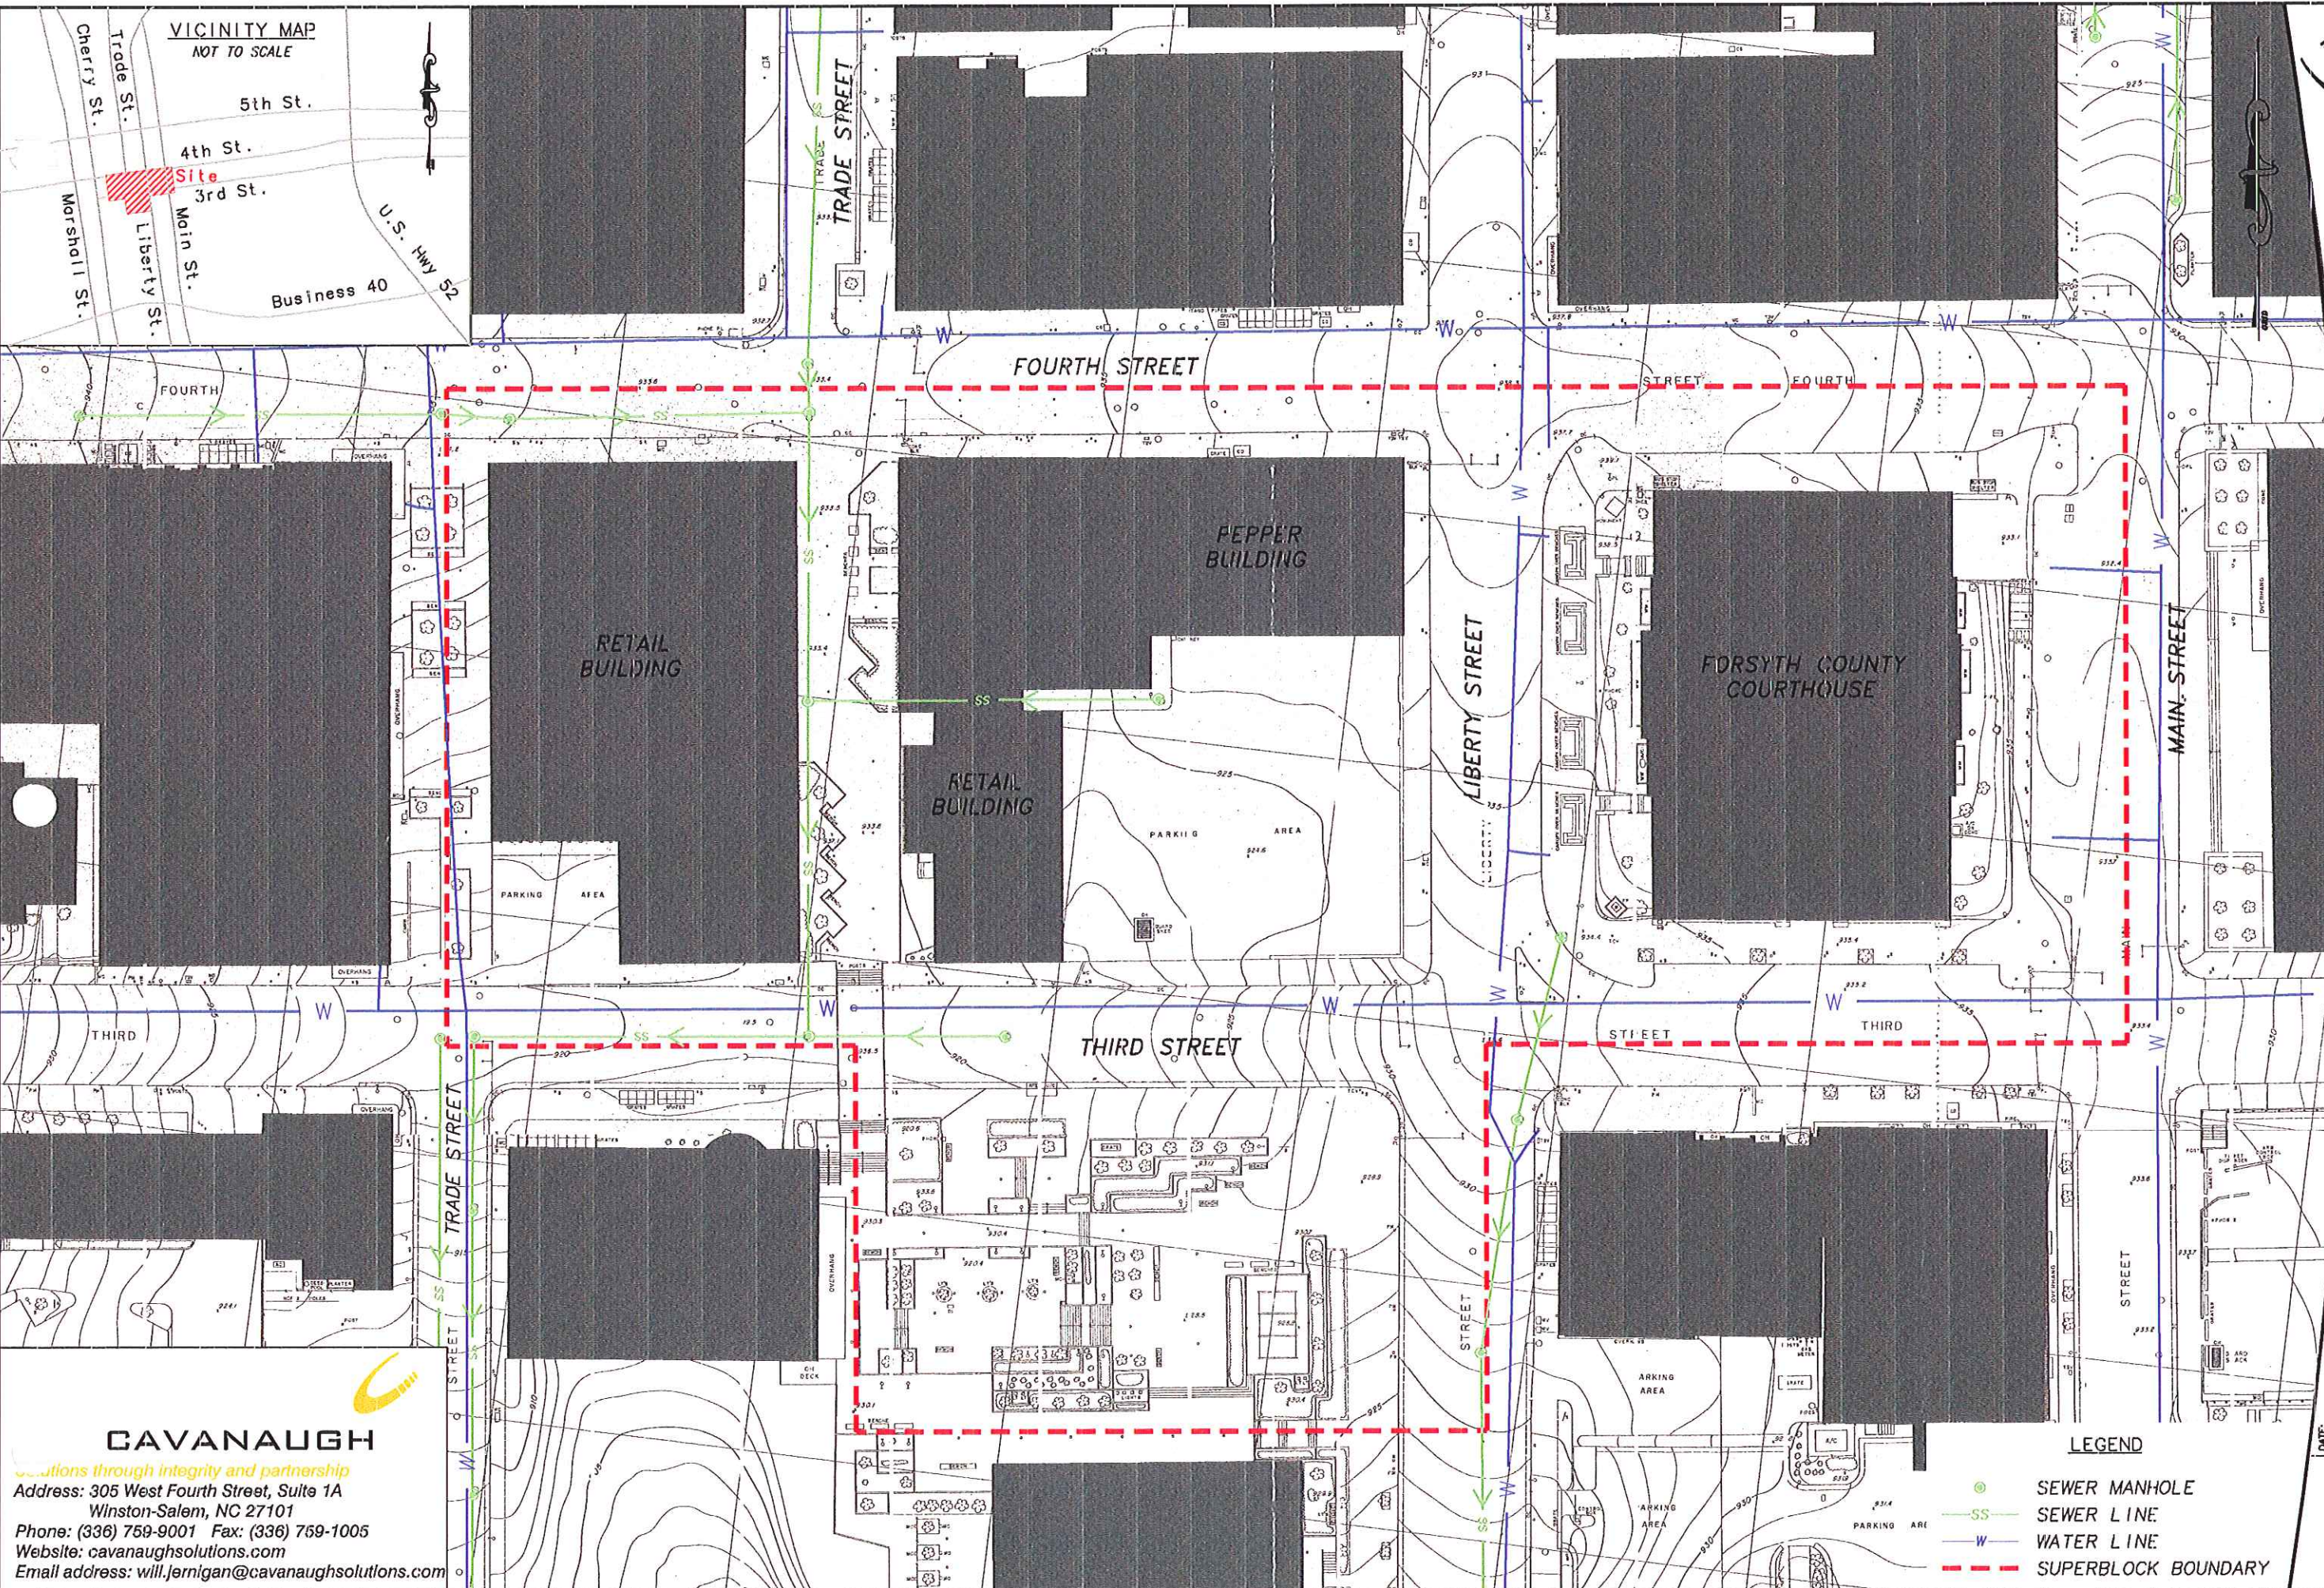

SUPERBLOCK
WINSTON-SALEM, FORSYTH COUNTY, NORTH CAROLINA

OVERALL SITE PLAN

CAVANAUGH

Solutions through integrity and partnership
Address: 305 West Fourth Street, Suite 1A
Winston-Salem, NC 27101
Phone: (336) 769-9001 Fax: (336) 769-1005
Website: cavanaughhsolutions.com
Email address: will.jernigan@cavanaughhsolutions.com

LEGEND

- SEWER MANHOLE
- SEWER LINE
- WATER LINE
- SUPERBLOCK BOUNDARY

DATE	SHEET NO.	REV.	DESCRIPTION	DATE
2/2005	1			
PROJECT NO.:				
DESIGNED:				
CHECKED:				
SCALE:	1"=60'			